




FRONT ELEVATION

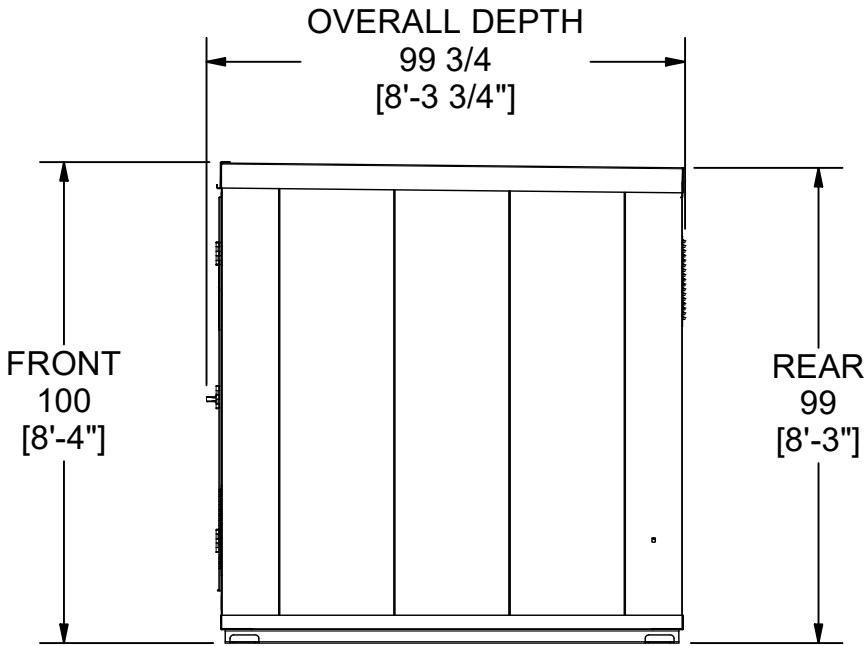

RIGHT ELEVATION

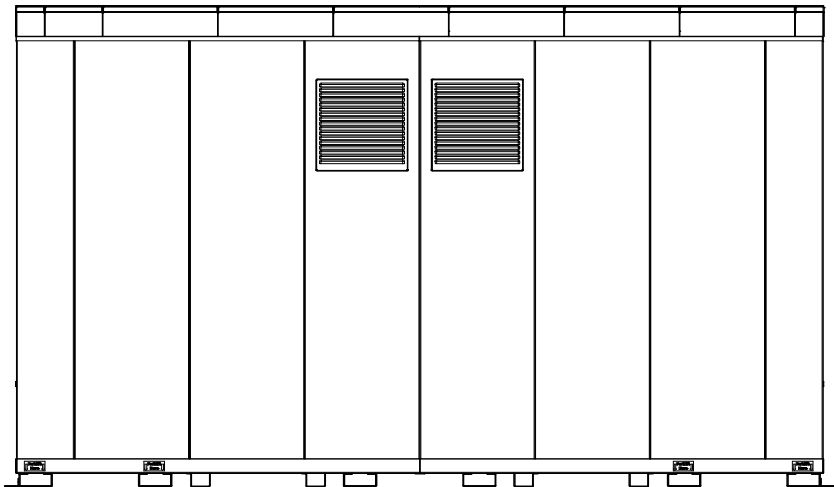

REAR ELEVATION

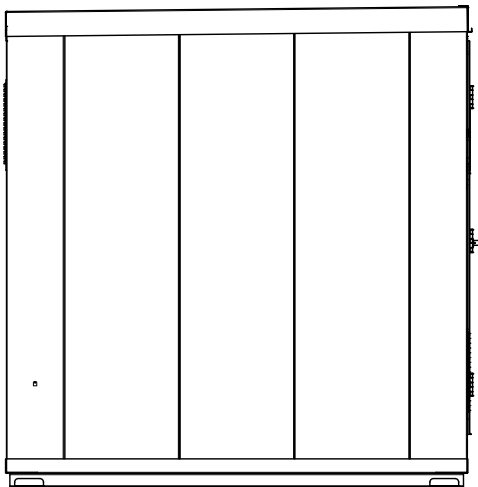

LEFT ELEVATION

MODEL: B2400
COLOR: BGRAY
FIRE RATING: 0 HRS.

QTY.

EXTERIOR DIMENSIONS (INCHES)	100H x 168W x 96D
INTERIOR AREA (SQ. FT.)	101.08
SUMP CAPACITY (GALLONS)	393

SHIPPING DIMENSIONS: 8'-4"H x 14'-4 7/8"W x 8'-3-3/4"D
SHIPPING WEIGHT: 6,994 LBS

CAUTION

A&A/Securall has made every attempt to interpret the specifications of your Purchase Order, as reflected in this drawing. By signing the "Approval" box, you the customer are approving the production specifications and the notes shown below. The products will be built in accordance with this drawing and invoiced as such. Deviations will be addressed in a revised drawing.

- IMPORTANT NOTES:**
1. All standard electrical is 120/240 volts, if installed.
 2. Location and quantity of devices, fixtures and conduit may vary based on product manufacturer's installation instructions, customer's requirements, electrician's recommendations and authority having jurisdiction.
 3. Revisions to customer drawings may result in increased engineering fees. Please consult with your sales representative for details.
 4. By signing this document you are accepting the possibility that State Design Certification may be required for your building and assume responsibility that you, the customer, will be invoiced accordingly if it is required.

DEALER /CONTRACTOR APPROVAL	END USER APPROVAL
SIGNATURE _____	SIGNATURE _____
PRINT NAME _____	PRINT NAME _____
DATE _____	DATE _____

NOTICE OF PROPRIETARY INFORMATION
THIS DOCUMENT AND THE INFORMATION HEREIN IS
CONFIDENTIAL AND PROPRIETARY OF A&A SHEET
METAL PRODUCTS, INC. IT MAY NOT BE REPRODUCED
IN WHOLE OR IN PART, OR DISCLOSED TO ANY THIRD
PARTY, OR USED WITHOUT THE PRIOR WRITTEN
CONSENT OF A&A SHEET METAL PRODUCTS, INC.

SMART certified
Sustainable Gold
Factory Mutual Approved
NO CHANGES ARE TO BE MADE
WITHOUT NOTIFICATION TO AND
APPROVAL FROM FACTORY MUTUAL
RESEARCH CORPORATION.

FM APPROVED

SECURALL®
Safety Storage Equipment

DESCRIPTION:
CUSTOMER APPROVAL
B2400

DRAWING: SBDC-B2400

DRAWN BY: CJM

DATE: 12/6/19

SHEET: 1 OF 2

UOM: INCHES
TOLERANCE: ±.50 ± 1°
REVISION: 0
SCALE: N.T.S.


STAMPS(S) IF APPLICABLE:

SITE LOCATION:


A&A Sheet Metal Products, Inc.
5122 N. STATE ROAD 39
LA PORTE, IN 46350
+1 (888) 326-7890




STAMP(S) IF APPLICABLE:

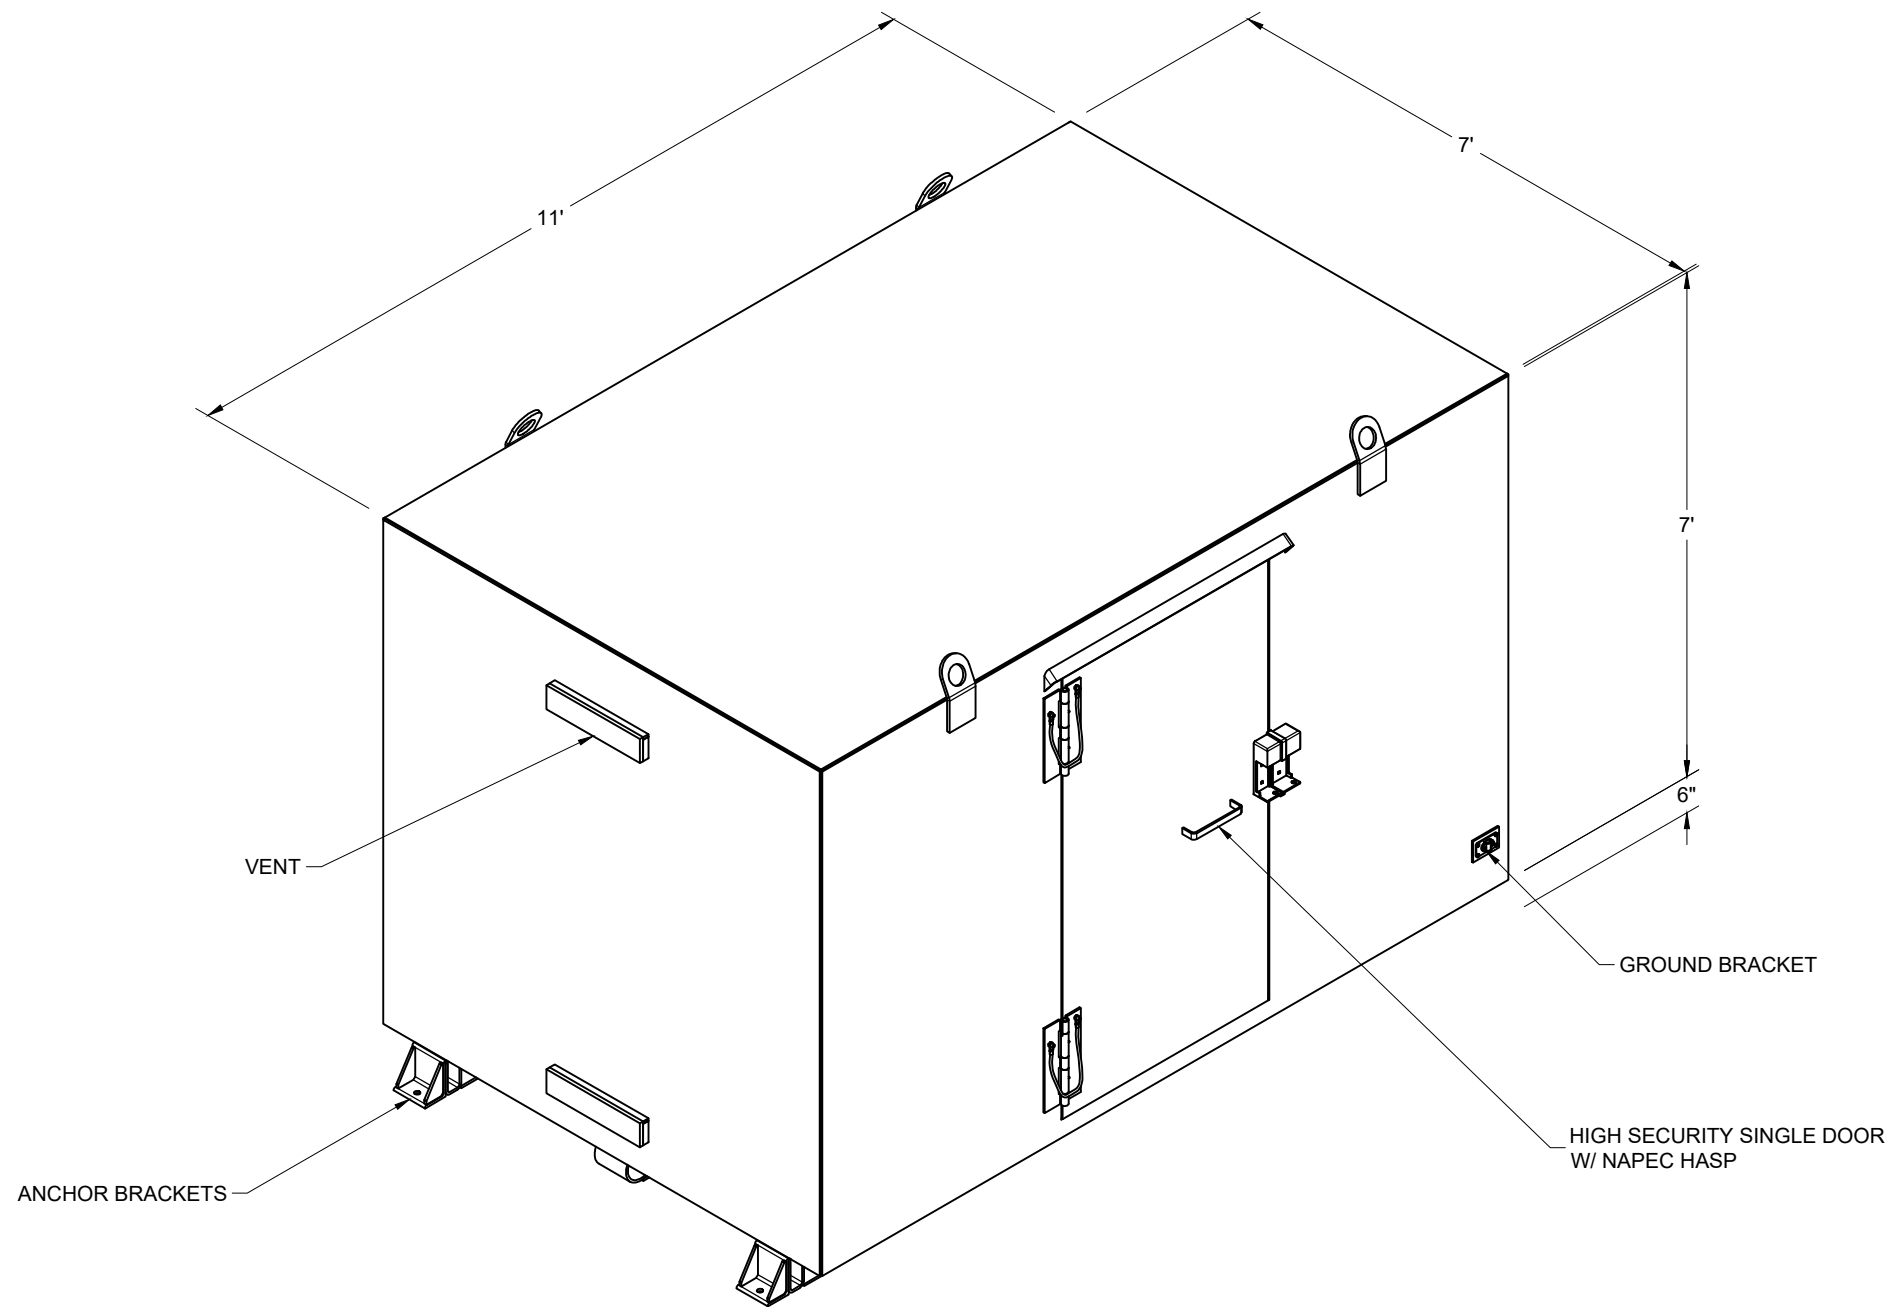


LEGEND: <div><div>⊙</div><div>⊕</div><div>⊕</div><div>DS</div><div>SS</div><div>EMR</div><div>T</div><div>SE</div><div>SM</div><div>PIR</div><div>BT</div></div>	LEGEND CONTINUED: <div><div>⊕</div><div>→</div></div>	UNLESS OTHERWISE NOTED, TOLERANCES ARE: FRACTIONS: ±1/16 ANGLES: ±1° MACHINED SURFACES: 125 MICRO-INCHES THESE TOLERANCES DO NOT APPLY TO BASIC DIMS. DRAWN TO SCALE UNLESS OTHERWISE NOTED THIS DRAWING IS THE PROPERTY OF ARMAG CORPORATION WHO CLAIMS PROPRIETARY RIGHTS IN THE MATERIAL DISCLOSED. IT IS ISSUED IN CONFIDENCE FOR ENGINEERING INFORMATION ONLY AND MAY NOT BE COPIED OR USED FOR MANUFACTURE OF ANYTHING SHOWN WITHOUT SPECIFIC PERMISSION FROM ARMAG CORPORATION	UNIT LENGTH 11'	UNIT WIDTH 7'	UNIT HEIGHT 7'	<div>ARMAG®</div> <div>C O R P O R A T I O N</div> <div>Manufacturers of Arms Vaults and Explosive Storage magazines since 1969</div> <div>300 ARMAG AVE. • BARDSTOWN, KY 40004 • PHONE: (800) 443-9994 • FAX: (502) 348-4801 • EMAIL: info@armagcorp.com</div>	DESCRIPTION TYPE 2 MAGAZINE		DRAWN BY RCY	REVISION 01
			UNIT SPEC TDS-2078-SHR	DATE DRAWN 12/29/2022						
			UNIT TYPE TYPE 2 MAGAZINE	APPROVED BY -						
			CUSTOMER USMC	SHEET SIZE B					APPROX. SHIPPING WT. IN LBS 11,400	
			LOCATION MCAS CHERRY POINT, NC	LINING 3" HARDWOOD			EXT. FINISH		SCALE 1:32	DRAWING NO. S3651
SERIAL #			QUOTE # 40192			SHEET 1 OF 2				

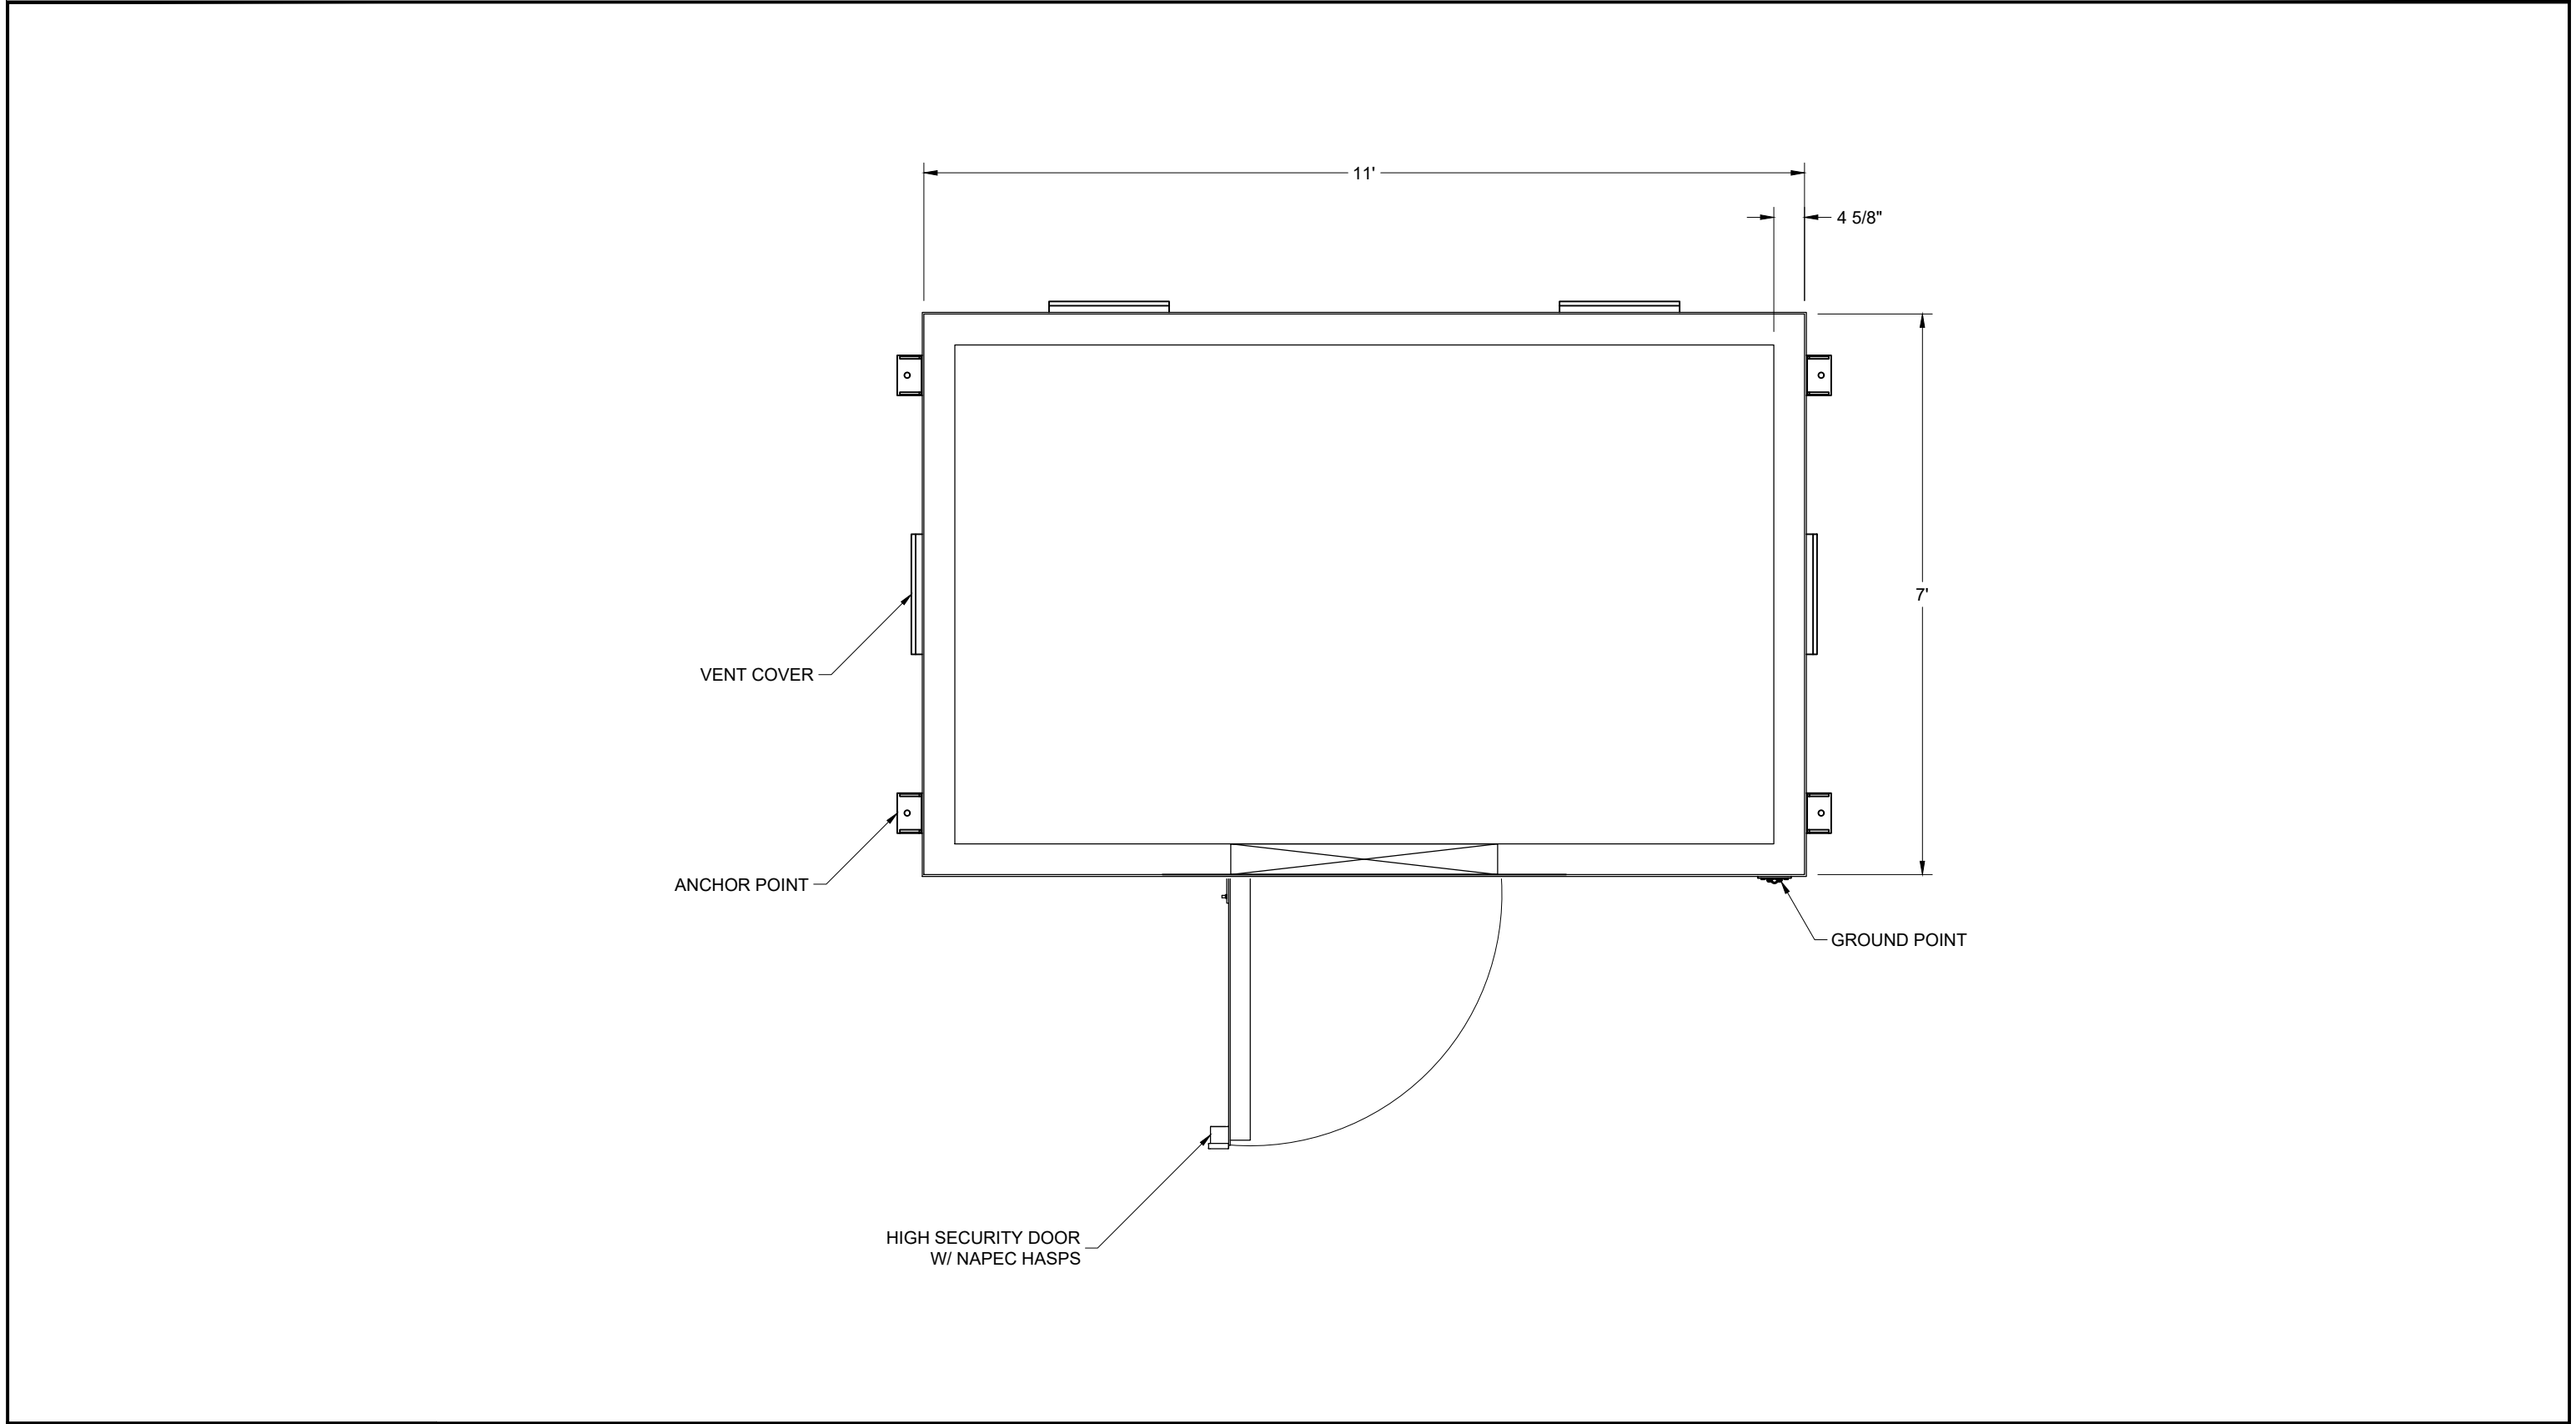

LEGEND:		LEGEND CONTINUED:		UNLESS OTHERWISE NOTED, TOLERANCES ARE: FRACTIONS: ±1/16 ANGLES: ±1° MACHINED SURFACES: 125 MICRO-INCHES THESE TOLERANCES DO NOT APPLY TO BASIC DIMS. DRAWN TO SCALE UNLESS OTHERWISE NOTED THIS DRAWING IS THE PROPERTY OF ARMAG CORPORATION WHO CLAIMS PROPRIETARY RIGHTS IN THE MATERIAL DISCLOSED. IT IS ISSUED IN CONFIDENCE FOR ENGINEERING INFORMATION ONLY AND MAY NOT BE COPIED OR USED FOR MANUFACTURE OF ANYTHING SHOWN WITHOUT SPECIFIC PERMISSION FROM ARMAG CORPORATION		UNIT LENGTH 11'		UNIT WIDTH 7'		UNIT HEIGHT 7'		<div><div><div>ARMAG®</div><div>CORPORATION</div><div>Manufacturers of Arms Vaults and Explosive Storage magazines since 1969</div><div>300 ARMAG AVE. • BARDSTOWN, KY 40004 • PHONE: (800) 443-9994 • FAX: (502) 348-4801 • EMAIL: info@armagcorp.com</div></div></div>				DESCRIPTION TYPE 2 MAGAZINE				DRAWN BY RCY		REVISION 01	
⊖ DURESS		⊕ THERMOSTAT				UNIT SPEC TDS-2078-SHR		UNIT TYPE TYPE 2 MAGAZINE		DATE DRAWN 12/29/2022						APPROVED BY -		APPROX. SHIPPING WT. IN LBS 11,400					
Ⓜ ELECTRIC RECEPTACLE		Ⓜ GROUND				CUSTOMER USMC		LOCATION MCAS CHERRY POINT, NC		SHEET SIZE B						SCALE 1:24		DRAWING NO. S3651					
DS DOUBLE STACKED						SERIAL # 40192		QUOTE # 40192		LINING 3" HARDWOOD						EXT. FINISH							
SS SINGLE STACKED																							
EMR EMERGENCY LIGHT																							
Ⓜ TELEPHONE JACK																							
Ⓜ LAN CONNECTION																							
SE SEISMIC SENSOR																							
SM SMOKE DETECTION																							
PIR PIR																							
BT BULLET TRAP																							

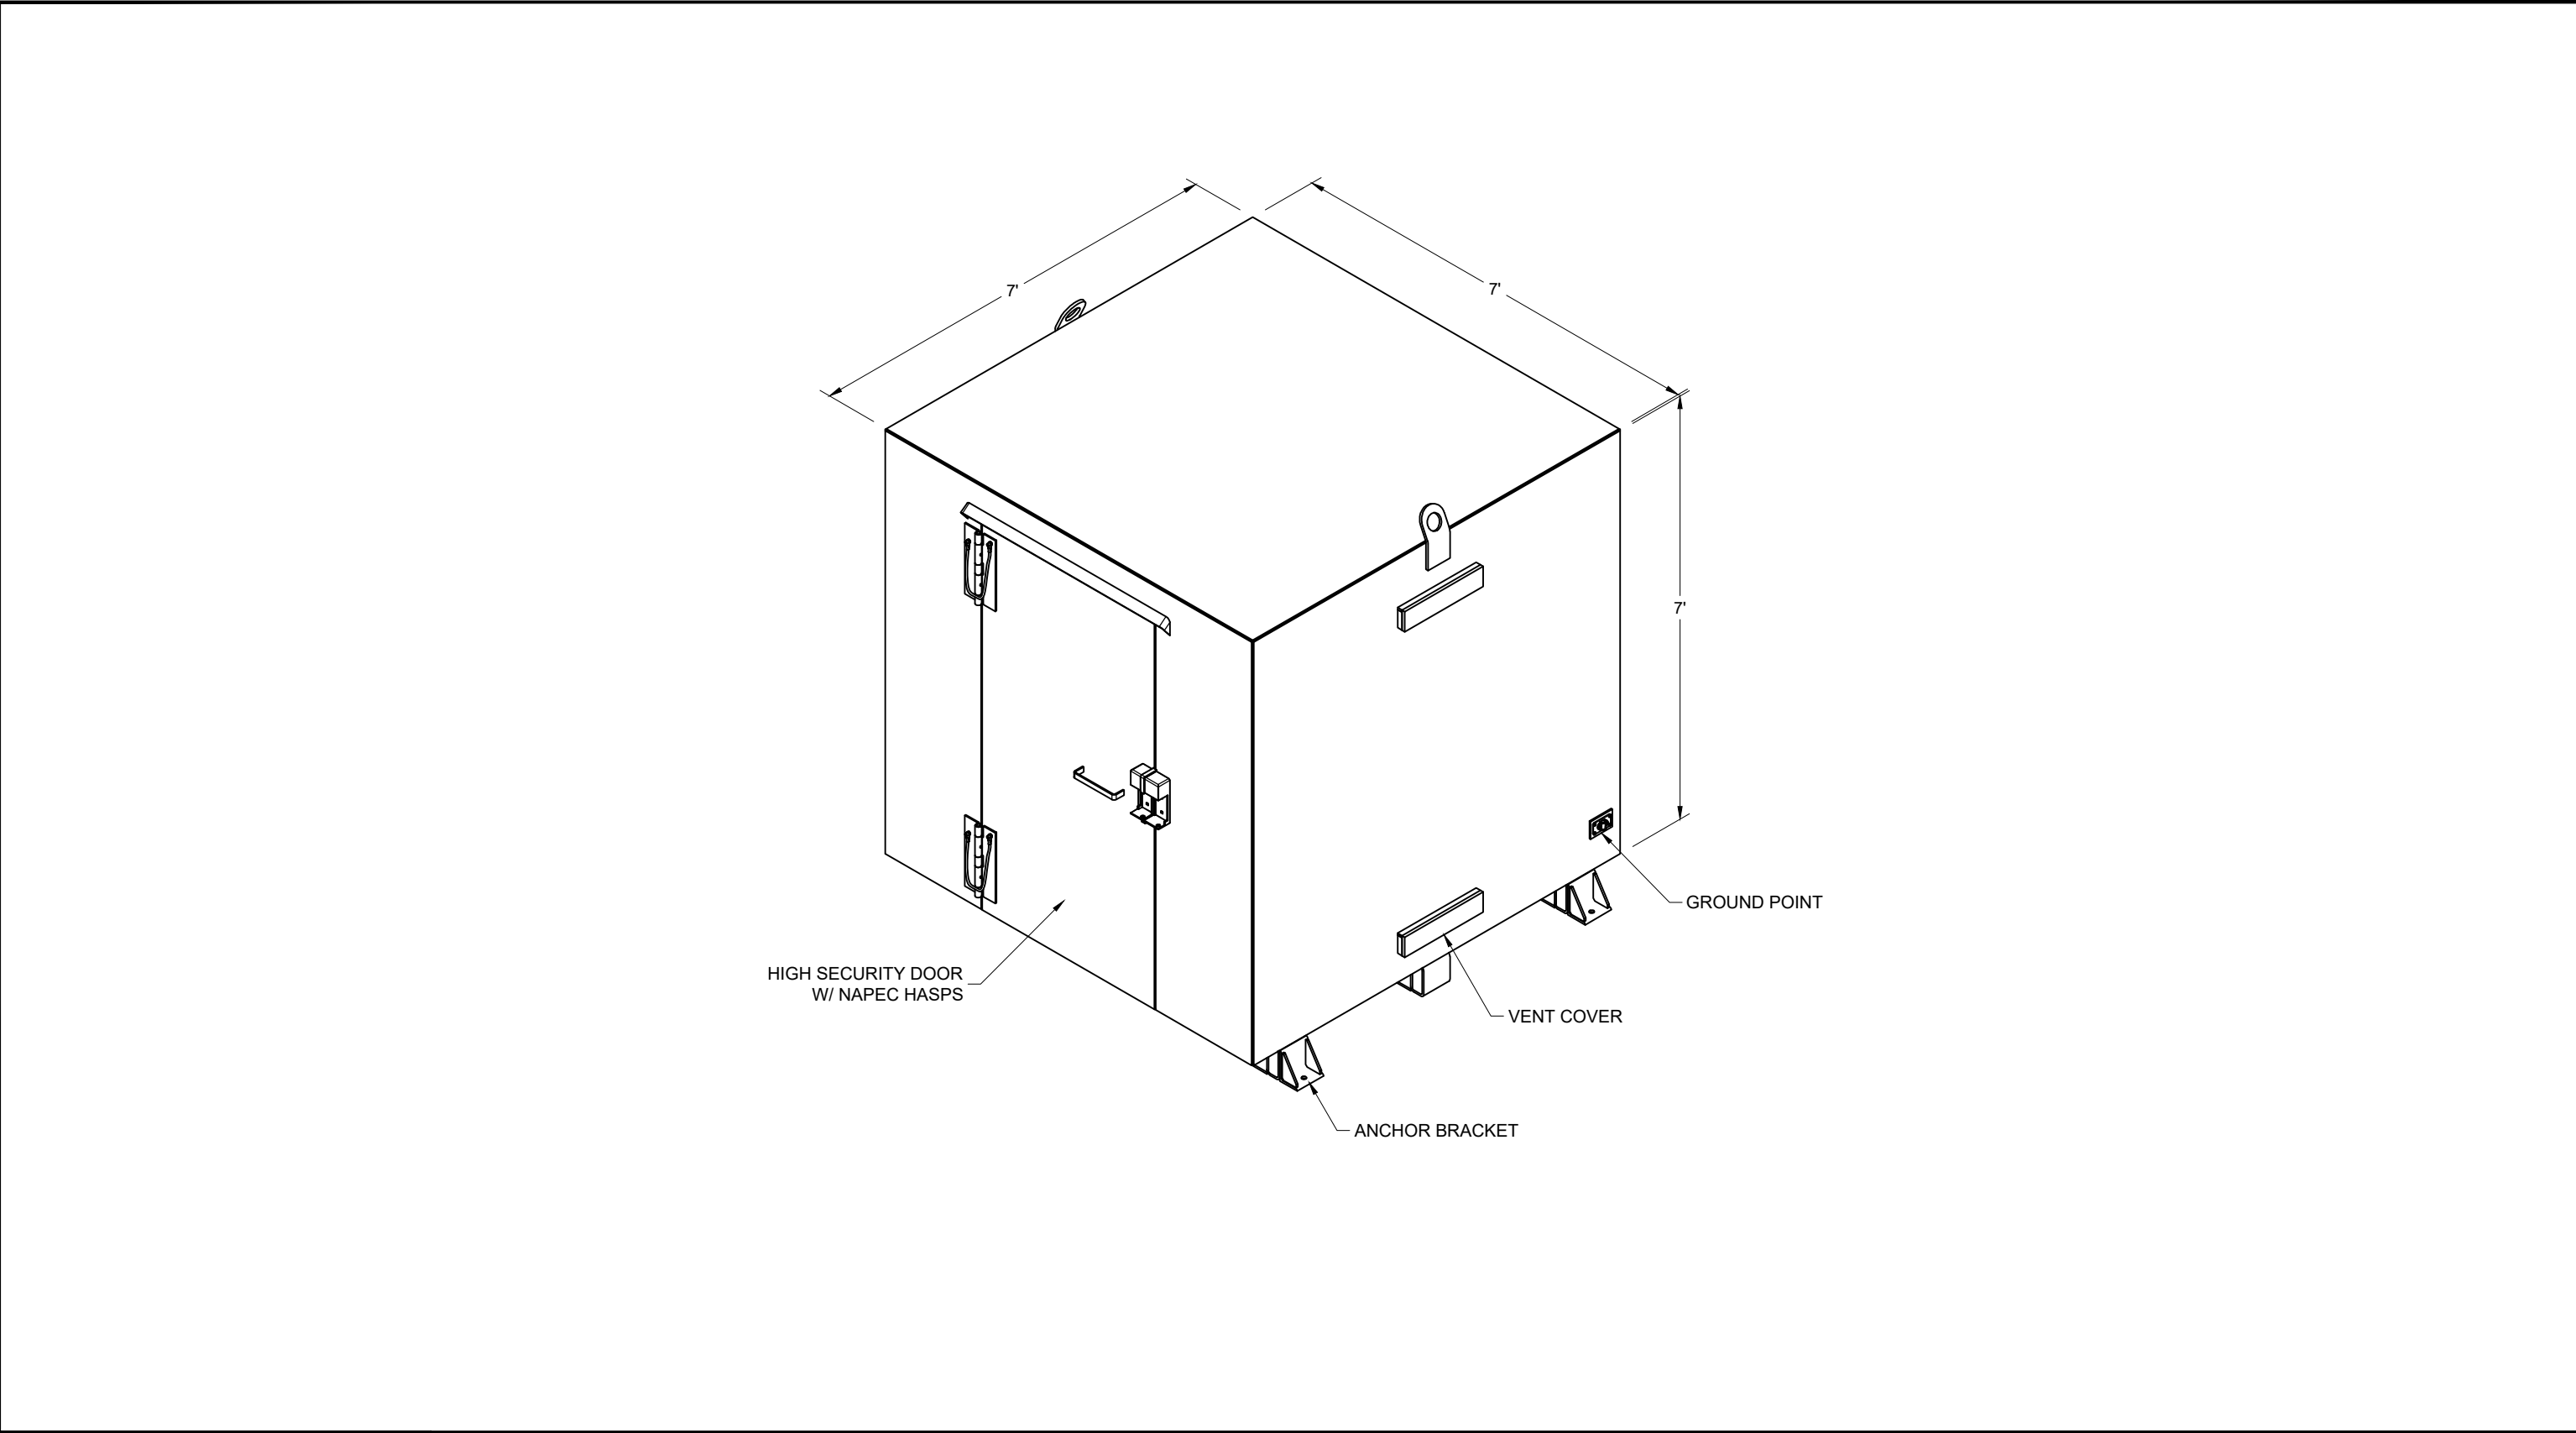

LEGEND:		LEGEND CONTINUED:		UNLESS OTHERWISE NOTED, TOLERANCES ARE: FRACTIONS: ±1/16 ANGLES: ±1° MACHINED SURFACES: 125 MICRO-INCHES THESE TOLERANCES DO NOT APPLY TO BASIC DIMS. DRAWN TO SCALE UNLESS OTHERWISE NOTED		UNIT LENGTH 7'	UNIT WIDTH 7'	UNIT HEIGHT 7'	<div> ARMAG® CORPORATION Manufacturers of Arms Vaults and Explosive Storage magazines since 1969 300 ARMAG AVE. • BARDSTOWN, KY 40004 • PHONE: (800) 443-9994 • FAX: (502) 348-4801 • EMAIL: info@armagcorp.com</div>	DESCRIPTION TYPE 2 MAGAZINE		DRAWN BY RCY	REVISION 01			
	KILL SWITCH		DURESS	THIS DRAWING IS THE PROPERTY OF ARMAG CORPORATION WHO CLAIMS PROPRIETARY RIGHTS IN THE MATERIAL DISCLOSED. IT IS ISSUED IN CONFIDENCE FOR ENGINEERING INFORMATION ONLY AND MAY NOT BE COPIED OR USED FOR MANUFACTURE OF ANYTHING SHOWN WITHOUT SPECIFIC PERMISSION FROM ARMAG CORPORATION		UNIT SPEC TDS-2078-SHR	UNIT TYPE TYPE 2 MAGAZINE			CUSTOMER USMC	LINING 3" HARDWOOD		EXT. FINISH		DATE DRAWN 12/29/2022	APPROX. SHIPPING WT. IN LBS 8,200
	ELECTRIC RECEPTACLE		THERMOSTAT			UNIT TYPE TYPE 2 MAGAZINE				CUSTOMER USMC					SHEET SIZE B	
	DOUBLE STACKED		GROUND			LOCATION MCAS CHERRY POINT, NC				LOCATION MCAS CHERRY POINT, NC					SCALE 1:32	
	SINGLE STACKED					SERIAL #	QUOTE # 40192					SHEET 1 OF 2	DRAWING NO. S3652			
	EMERGENCY LIGHT															
	TELEPHONE JACK															
	LAN CONNECTION															
	SEISMIC SENSOR															
	SMOKE DETECTION															
	PIR															
	BULLET TRAP															

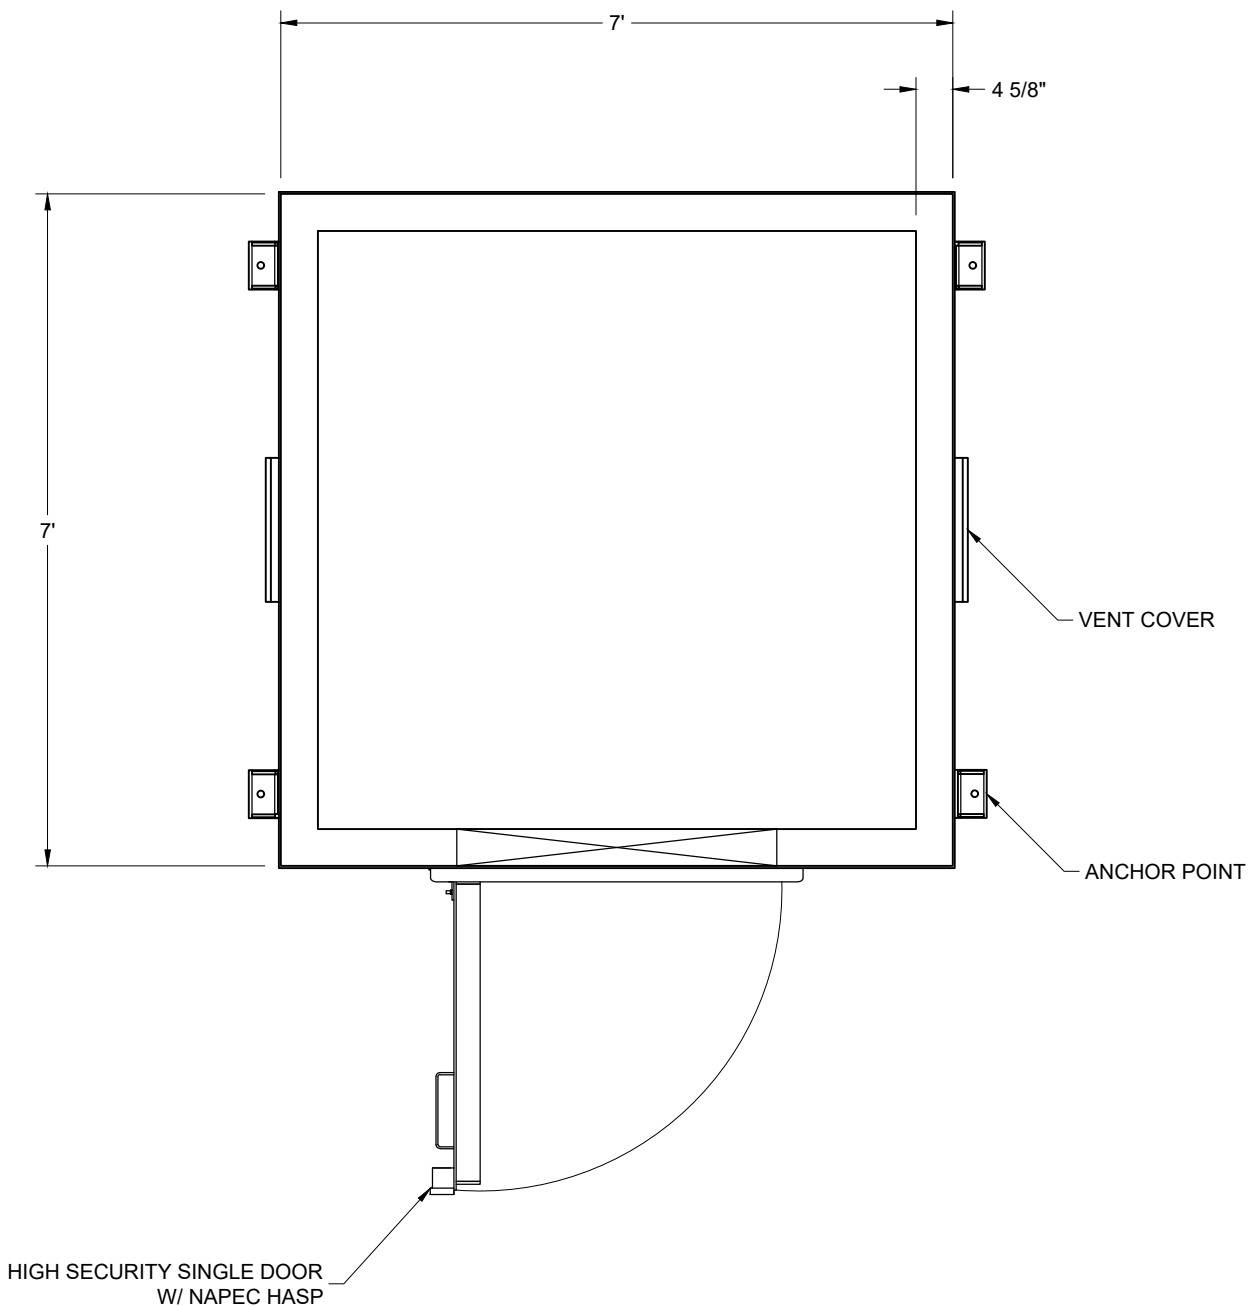

LEGEND:		LEGEND CONTINUED:		UNLESS OTHERWISE NOTED, TOLERANCES ARE: FRACTIONS: ±1/16 ANGLES: ±1° MACHINED SURFACES: 125 MICRO-INCHES THESE TOLERANCES DO NOT APPLY TO BASIC DIMS. DRAWN TO SCALE UNLESS OTHERWISE NOTED		UNIT LENGTH 7'	UNIT WIDTH 7'	UNIT HEIGHT 7'	 ARMAG® CORPORATION Manufacturers of Arms Vaults and Explosive Storage magazines since 1969 300 ARMAG AVE. • BARDSTOWN, KY 40004 • PHONE: (800) 443-9994 • FAX: (502) 348-4801 • EMAIL: info@armagcorp.com	DESCRIPTION TYPE 2 MAGAZINE		DRAWN BY RCY	REVISION 01
⊙	KILL SWITCH	⊕	THERMOSTAT	THIS DRAWING IS THE PROPERTY OF ARMAG CORPORATION WHO CLAIMS PROPRIETARY RIGHTS IN THE MATERIAL DISCLOSED. IT IS ISSUED IN CONFIDENCE FOR ENGINEERING INFORMATION ONLY AND MAY NOT BE COPIED OR USED FOR MANUFACTURE OF ANYTHING SHOWN WITHOUT SPECIFIC PERMISSION FROM ARMAG CORPORATION	UNIT SPEC TDS-2078-SHR	UNIT TYPE TYPE 2 MAGAZINE		CUSTOMER USMC		DATE DRAWN 12/29/2022	APPROX. SHIPPING WT. IN LBS 8,200	DRAWING NO. S3652	
⊖	DURESS	⊕	GROUND		LOCATION MCAS CHERRY POINT, NC	SERIAL #	QUOTE # 40192	LINING 3" HARDWOOD		EXT. FINISH			APPROVED BY -
⊕	ELECTRIC RECEPTACLE												SHEET SIZE B
DS	DOUBLE STACKED												SCALE 1:24
SS	SINGLE STACKED												
EMR	EMERGENCY LIGHT												
Ⓟ	TELEPHONE JACK												
Ⓡ	LAN CONNECTION												
SE	SEISMIC SENSOR												
SM	SMOKE DETECTION												
PIR	PIR												
BT	BULLET TRAP												